


F.M. 1825
(PECAN STREET WEST)
(120' R.O.W.)
(ASPHALT PAVEMENT)

SARAH'S CREEK DRIVE
(R.O.W. WIDTH VARIES)
(ASPHALT PAVEMENT)
(30 M.P.H.)

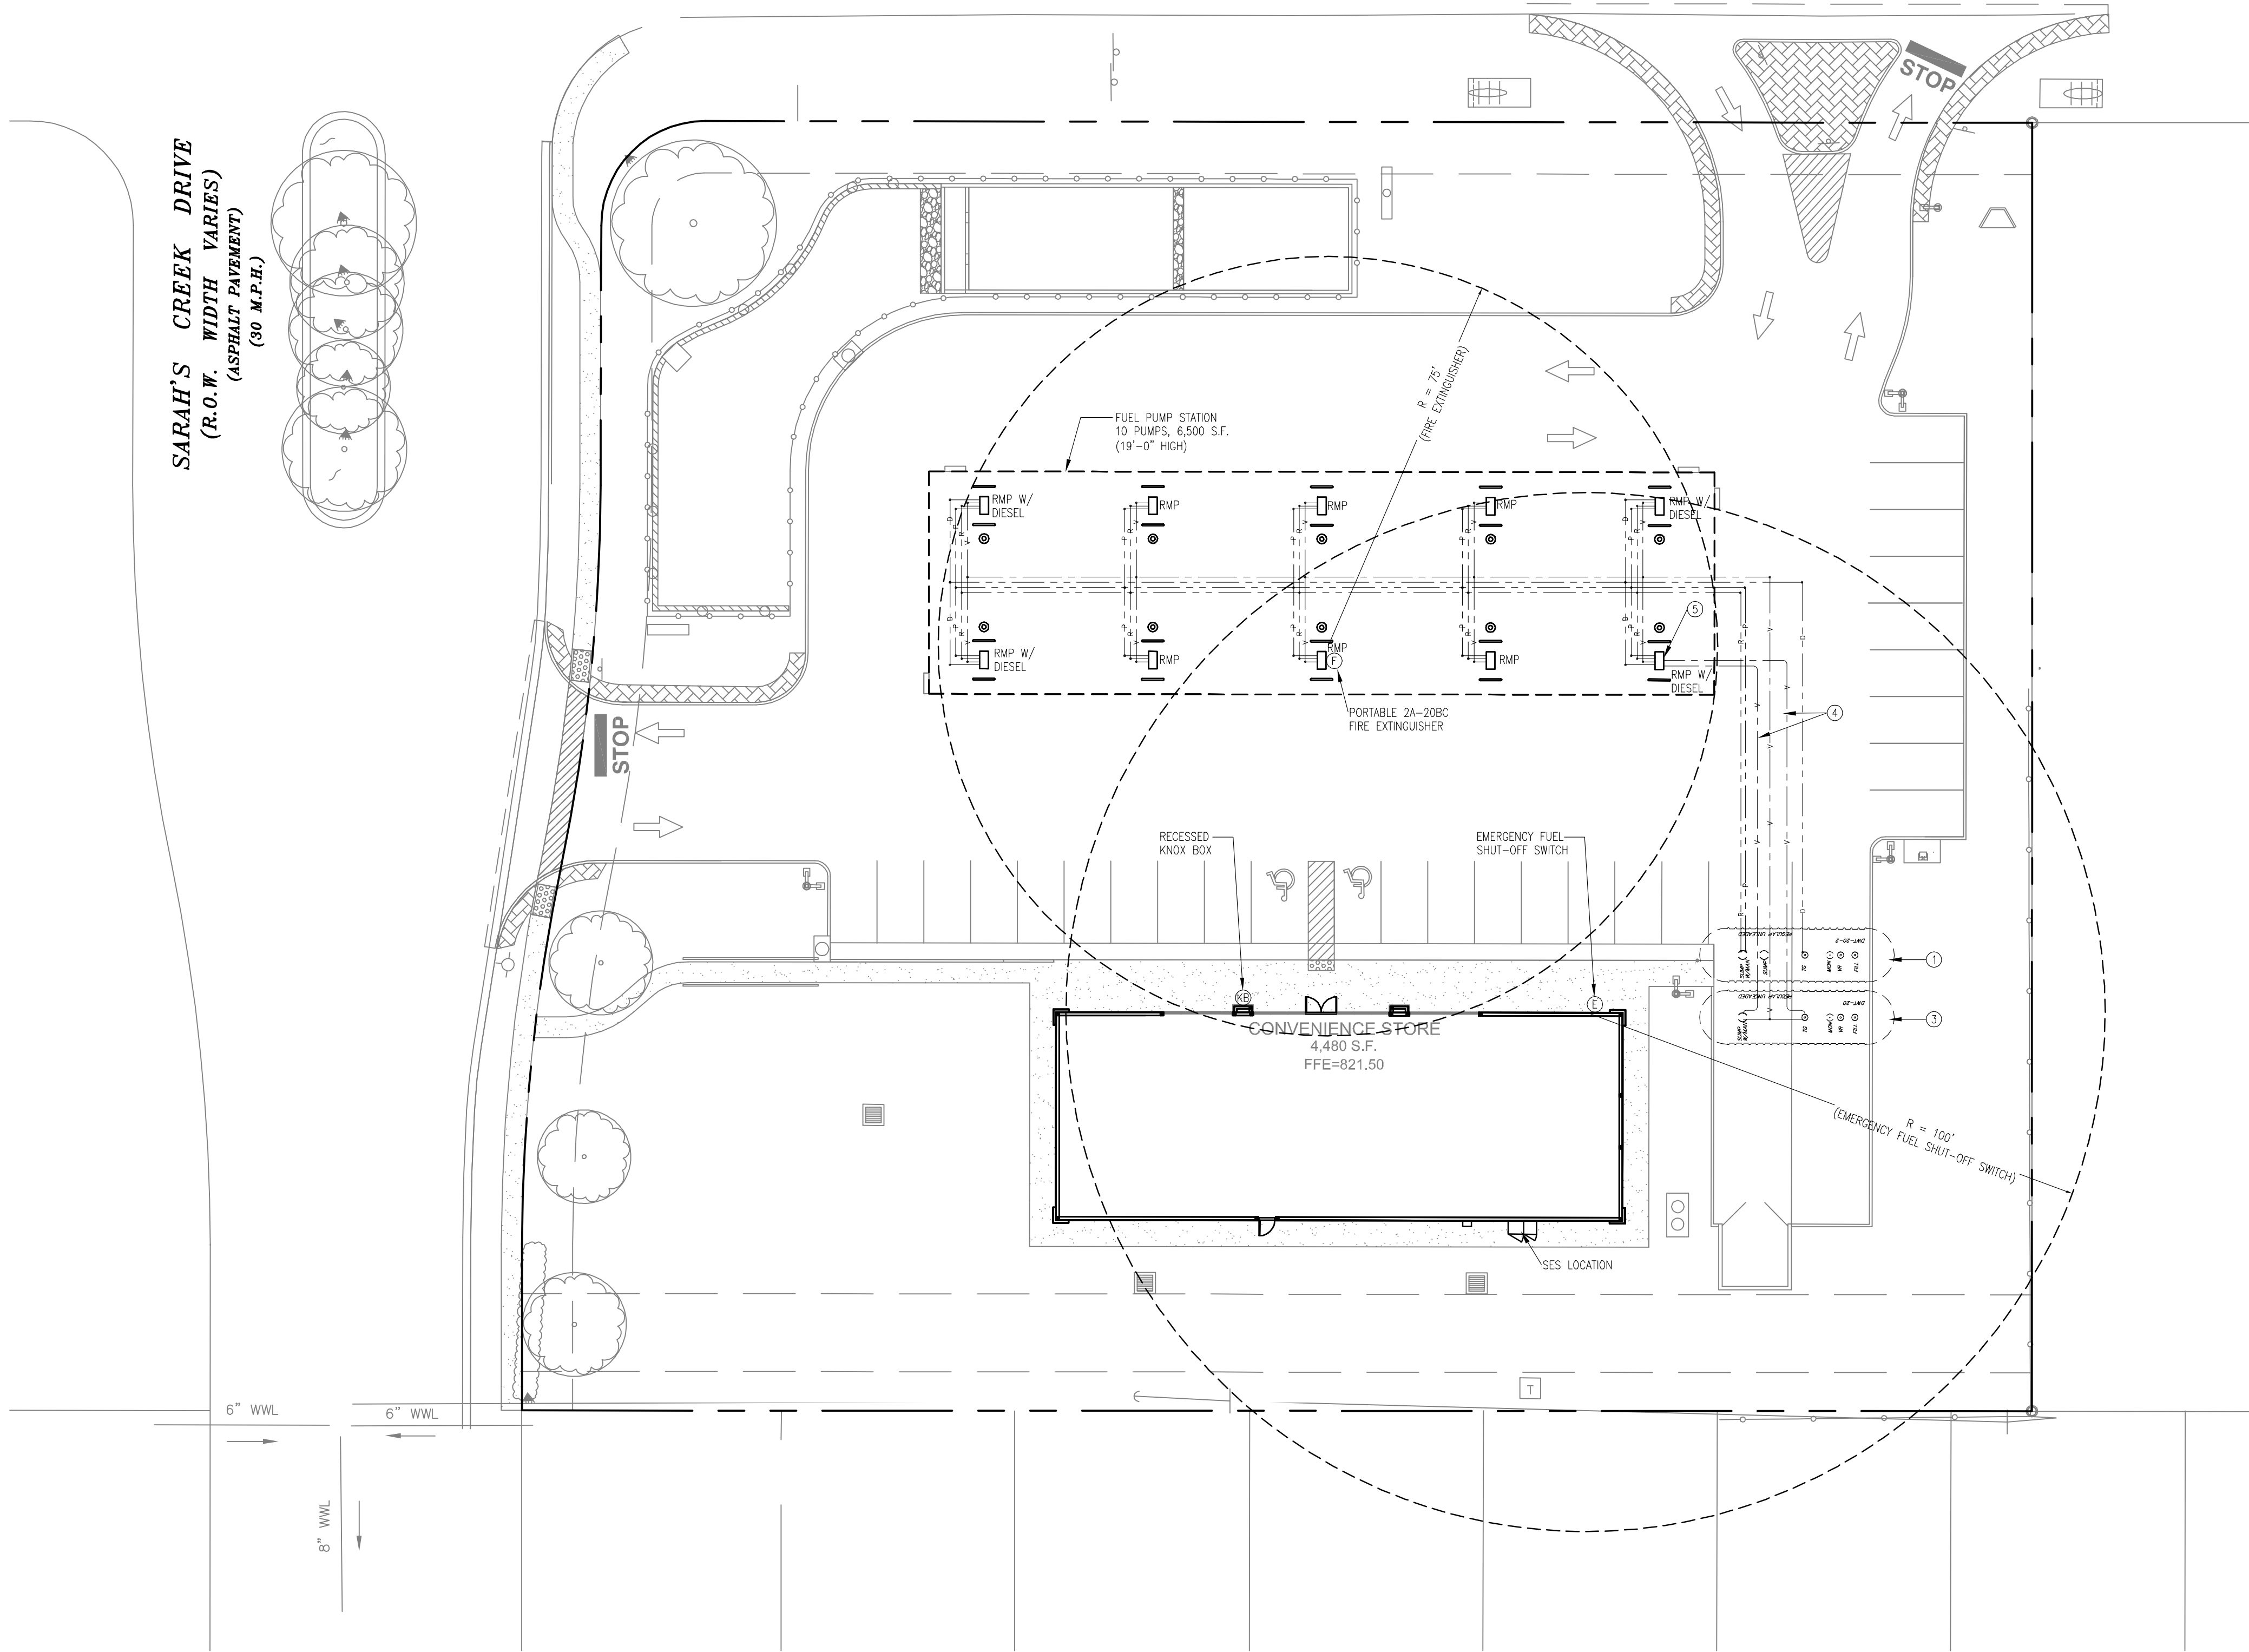

KEYED NOTES

- 20,000 GALLON REGULAR UNLEADED UNDERGROUND TANK.
- NOT USED
- 20,000 GALLON DIESEL UNLEADED UNDERGROUND TANK.
- FUEL VENT FROM TANKS
- VENT RISER SCREENED AT COLUMN, SEE DETAIL 7/F3.2

LEGEND

- R = REGULAR UNLEADED
M = MID-GRADE UNLEADED (REGULAR & PREMIUM BLEND)
P = PREMIUM UNLEADED
D = DIESEL
(E) = EMERGENCY FUEL SHUTOFF SWITCH
(F) = FIRE EXTINGUISHER
(KB) = KNOX BOX, SEE DETAILS B5/A12.1

GENERAL NOTES

- PETROLEUM PIPING SHOWN SCHEMATICALLY. CONTRACTOR SHALL INSTALL PIPING PER FIELD CONDITIONS WITH CIRCLE K REPRESENTATIVE'S APPROVAL.
- SEE IRRIGATION DRAWINGS FOR IRRIGATION PIPING PLAN.
- SEE BUILDING DRAWINGS FOR BUILDING PLUMBING.
- SEE FUEL SYSTEMS PLANS AND FUEL CANOPY PLANS FOR MORE INFORMATION.
- APPROVED PORTABLE FIRE EXTINGUISHER COMPLYING WITH 2009 IFC SECTION 906 WITH A MINIMUM RATING OF 2-A-20-B-C SHALL BE PROVIDED AND LOCATED SUCH THAT AN EXTINGUISHER IS NOT MORE THAN 75 FEET FROM PUMPS, DISPENSERS, OR STORAGE TANK FILL-PIPE OPENINGS. (2009 IFC 2205.5)
- AN APPROVED, CLEARLY IDENTIFIED, AND READILY ACCESSIBLE EMERGENCY FUEL SHUT-OFF SWITCH COMPLYING WITH 2009 IFC SECTION 2203.2 SHALL BE PROVIDED AND LOCATED NO FURTHER 100 FEET TRAVEL DISTANCE, BUT NOT LESS THAN 20 FEET FROM THE FUEL DISPENSERS. SUCH DEVICE SHALL BE DISTINCTLY LABELED AS: "EMERGENCY FUEL SHUTOFF".
- WARNING SIGNS SHALL BE CONSPICUOUSLY POSTED WITHIN SIGHT OF EACH DISPENSER IN THE FUEL DISPENSING AREA AND SHALL STATE THE FOLLOWING: 1) NO SMOKING; 2) SHUT OFF MOTOR; 3)DISCHARGE YOUR STATIC ELECTRICITY BEFORE FUELING BY TOUCHING A METAL SURFACE AWAY FROM THE NOZZLE; 4) TO PREVENT STATIC CHARGE, DO NOT REENTER YOUR VEHICLE WHILE GASOLINE IS PUMPING; 5) IF A FIRE STARTS, DO NOT REMOVE NOZZLE - BACK AWAY IMMEDIATELY; 6) IT IS UNLAWFUL AND DANGEROUS TO DISPENSE GASOLINE INTO UNAPPROVED CONTAINER; 7) NO FILLING OF PORTABLE CONTAINERS IN OR ON A MOTOR VEHICLE. PLACE CONTAINER ON GROUND BEFORE FILLING. (2009 IFC 2205.6)
- THE ATTENDANT SHALL BE ABLE TO COMMUNICATE WITH PERSONS IN THE DISPENSING AREA AT ALL TIMES. AN APPROVED METHOD OF COMMUNICATING WITH THE FIRE DEPARTMENT SHALL BE PROVIDED FOR THE ATTENDANT. (2009 IFC 2204.2.5)
- DISPENSING DEVICES SHALL BE IN CLEAR VIEW OF THE ATTENDANT AT ALL TIMES. OBSTRUCTING SHALL NOT BE PLACED BETWEEN THE DISPENSING AREA AND THE ATTENDANT. (2009 IFC 2204.2.4)
- KNOX BOXES SHALL BE LOCATED AT THE FRONT ENTRY AND THE FIRE RISER ROOF EXTERIOR DOOR. IF NO EXTERIOR DOOR LEADS TO THE FIRE RISER ROOM THEN A KNOX BOX SHALL BE LOCATED AT THE NEAREST DOOR LEADING TO THE FIRE RISER LOCATION.

GreenbergFarrow

265 Davidson Avenue, Suite 400
Somerset, NJ 08873
t: 732 537 0811 f: 732 537 0831

COPYRIGHT NOTICE

This drawing is the property of the above referenced Professional and is not to be used for any purpose other than the specific project and site named herein, and cannot be reproduced in any manner without the express written permission from the Professional

ISSUE/REVISION RECORD

DATE	DESCRIPTION
02/28/2014	PERMIT/BID SET

PROFESSIONAL SEAL

PROFESSIONAL IN CHARGE

DOUGLAS COOPER

PROJECT MANAGER

CHRIS CERBO

QUALITY CONTROL

WARREN DRURY

DRAWN BY


RP

PROJECT NAME

CIRCLE K
STORES, INC.

PFLUGERVILLE
TEXAS

SEC WEST PECAN ST. &
SARAH'S CREEK DR.
PFLUGERVILLE, TX

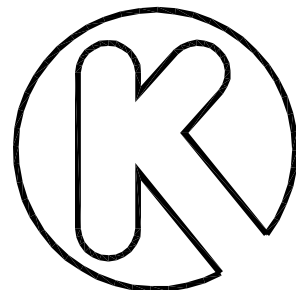

CIRCLE K STORES INC.

PROJECT NUMBER

20140041.5

SHEET TITLE

FUEL PIPING
FLOOR PLAN

SHEET NUMBER

F1.0